


LEGEND

PROPOSED FEATURES	
PUMPSTATION	
SEPTIC TANK	
FLARED END SECTION	
TREELINE	
FENCE	
CONTOUR	
SWALE	
STONE WALL	
PROPERTY LINE	
EDGE OF PAVEMENT	
SANITARY SEWER LINE	
STORM LINE	
FORCE MAIN LINE	

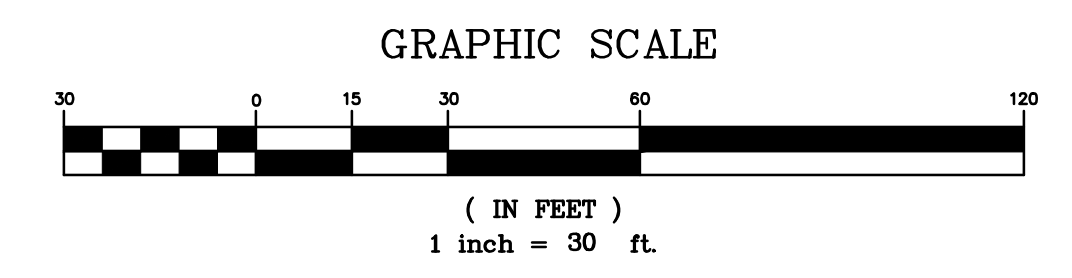

Rev. No.	Description

ENGINEERING VENTURES PC
 208 Flynn Avenue, Suite 2A Burlington, VT 05401
 Tel: 802.863.6225 • Fax: 802.863.6306
 85 Mechanic Street, Suite 300A, Lebanon, NH 03766
 Tel: 603.442.2533 • Fax: 603.442.2531
 www.engineeringventures.com

Client: Circus Smirkus
 1 Circus Road
 Greensboro, VT 05841
 Ph: (802)533-7443

Sheet Title: **MAIN AREA SITE UTILITY AND GRADING PLAN**
 Project Title: **CIRCUS SMIRKUS SUMMER CAMP GREENSBORO, VT**
 Designed By: JZ
 Checked By: JZ
 Drawn By: DZ
 Scale: AS NOTED
 Date: 5/16/2013

C1.2
 EV#11722